
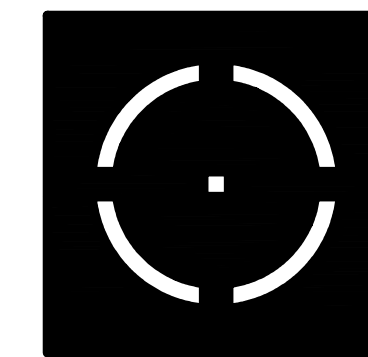
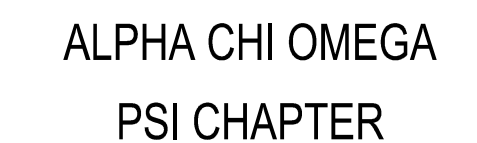


-AIR CONDITIONER -ALPHA BOX -AUTO SPRINKLER -FIRE ALARM -FLAG MON. -BUSH -CLEAN OUT -DOWN SPOUT -ELECTRIC METER	-ELECTRIC MANHOLE -ELECTRIC MARKER -ELECTRIC UTILITY RISER -ELECTRIC VALVE -TRANSFORMER -FRENCH DRAIN -FIRE HYDRANT -FLAG POLE -FIRE VALVE -GUY ANCHOR -GAS METER	-GAS MARKER -GREASE POST -GREASE TRAP -PARKING POLE -POWER POLE -POWER POLE WITH SERVICE -QUARTER CORNER NORTH-EAST -QUARTER CORNER NORTH-SOUTH -REFERENCE POINT -SMALL BOX -MONITORING WELL	-MISC. MARKER -PIER -PULLBOX -SANITARY SEWER LIFT STATION -SANITARY SEWER MANHOLE -POWER POLE -STORM SEWER MANHOLE -TRAFFIC CONTROL -TELEPHONE MARKER -TELEPHONE PEDESTAL	-SCV CONTROL VALVE -TREE -TRAFFIC SIGNAL LIGHT -MANHOLE -TV MARKER -TV PEDESTAL -ROUND WATER METER -WATER MARKER -WATER METER PIT	-WATER MANHOLE -SEWER TREE -SQUARE WATER -WATER SHUTOFF (SPOOL) -WATER VALVE -WATER WELL -YARD LIGHT -BM #1, XXX' -ROAD -TREE LINE -UNDERGROUND TELEPHONE -ONE-WAY ELECTRIC -BARBED WIRE FENCE
-F/O UNDERGROUND FIBER OPTIC -U/TV UNDERGROUND TELEVISION	-G/G UNDERGROUND GAS -U/E UNDERGROUND ELECTRIC	-STS UNDERGROUND STORM SEWER -W UNDERGROUND WATER -C/N UNDERGROUND COLD WATER -O/E OVERHEAD ELECTRIC -CHAIN LINK FENCE	-SS UNDERGROUND SANITARY SEWER -C/W UNDERGROUND COLD WATER -O/E OVERHEAD ELECTRIC -STOCKADE FENCE	-SS UNDERGROUND SANITARY SEWER -C/W UNDERGROUND COLD WATER -O/E OVERHEAD ELECTRIC -STOCKADE FENCE	-TUG UNDERGROUND TELEPHONE -O/E OVERHEAD ELECTRIC -BARBED WIRE FENCE
-F/O OVERHEAD FIBER OPTIC -U/TV OVERHEAD TELEVISION	-G/G OVERHEAD GAS -U/E OVERHEAD ELECTRIC	-STS OVERHEAD STORM SEWER -W OVERHEAD WATER -C/N OVERHEAD COLD WATER -O/E OVERHEAD ELECTRIC -CHAIN LINK FENCE	-SS OVERHEAD SANITARY SEWER -C/W OVERHEAD COLD WATER -O/E OVERHEAD ELECTRIC -STOCKADE FENCE	-SS OVERHEAD SANITARY SEWER -C/W OVERHEAD COLD WATER -O/E OVERHEAD ELECTRIC -STOCKADE FENCE	-TUG OVERHEAD TELEPHONE -O/E OVERHEAD ELECTRIC -BARBED WIRE FENCE

**BOCKUS PAYNE
ARCHITECTURE**

6303 Waterford Blvd. Suite 240
Oklahoma City, OK 73118
p 405-842-0858 | f 405-843-8959
www.bockus-payne.com

COPYRIGHT 2018 BOCKUS PAYNE ASSOCIATES
ARCHITECTS, P.C. ALL RIGHTS RESERVED. THIS
DRAWING IS PROPERTY OF BOCKUS PAYNE
ASSOCIATES ARCHITECTS. ANY MODIFICATION OR USE
OF THIS DRAWING WITHOUT EXPRESS WRITTEN
AUTHORIZATION OF BOCKUS PAYNE ASSOCIATES
ARCHITECTS, P.C. IS PROHIBITED.

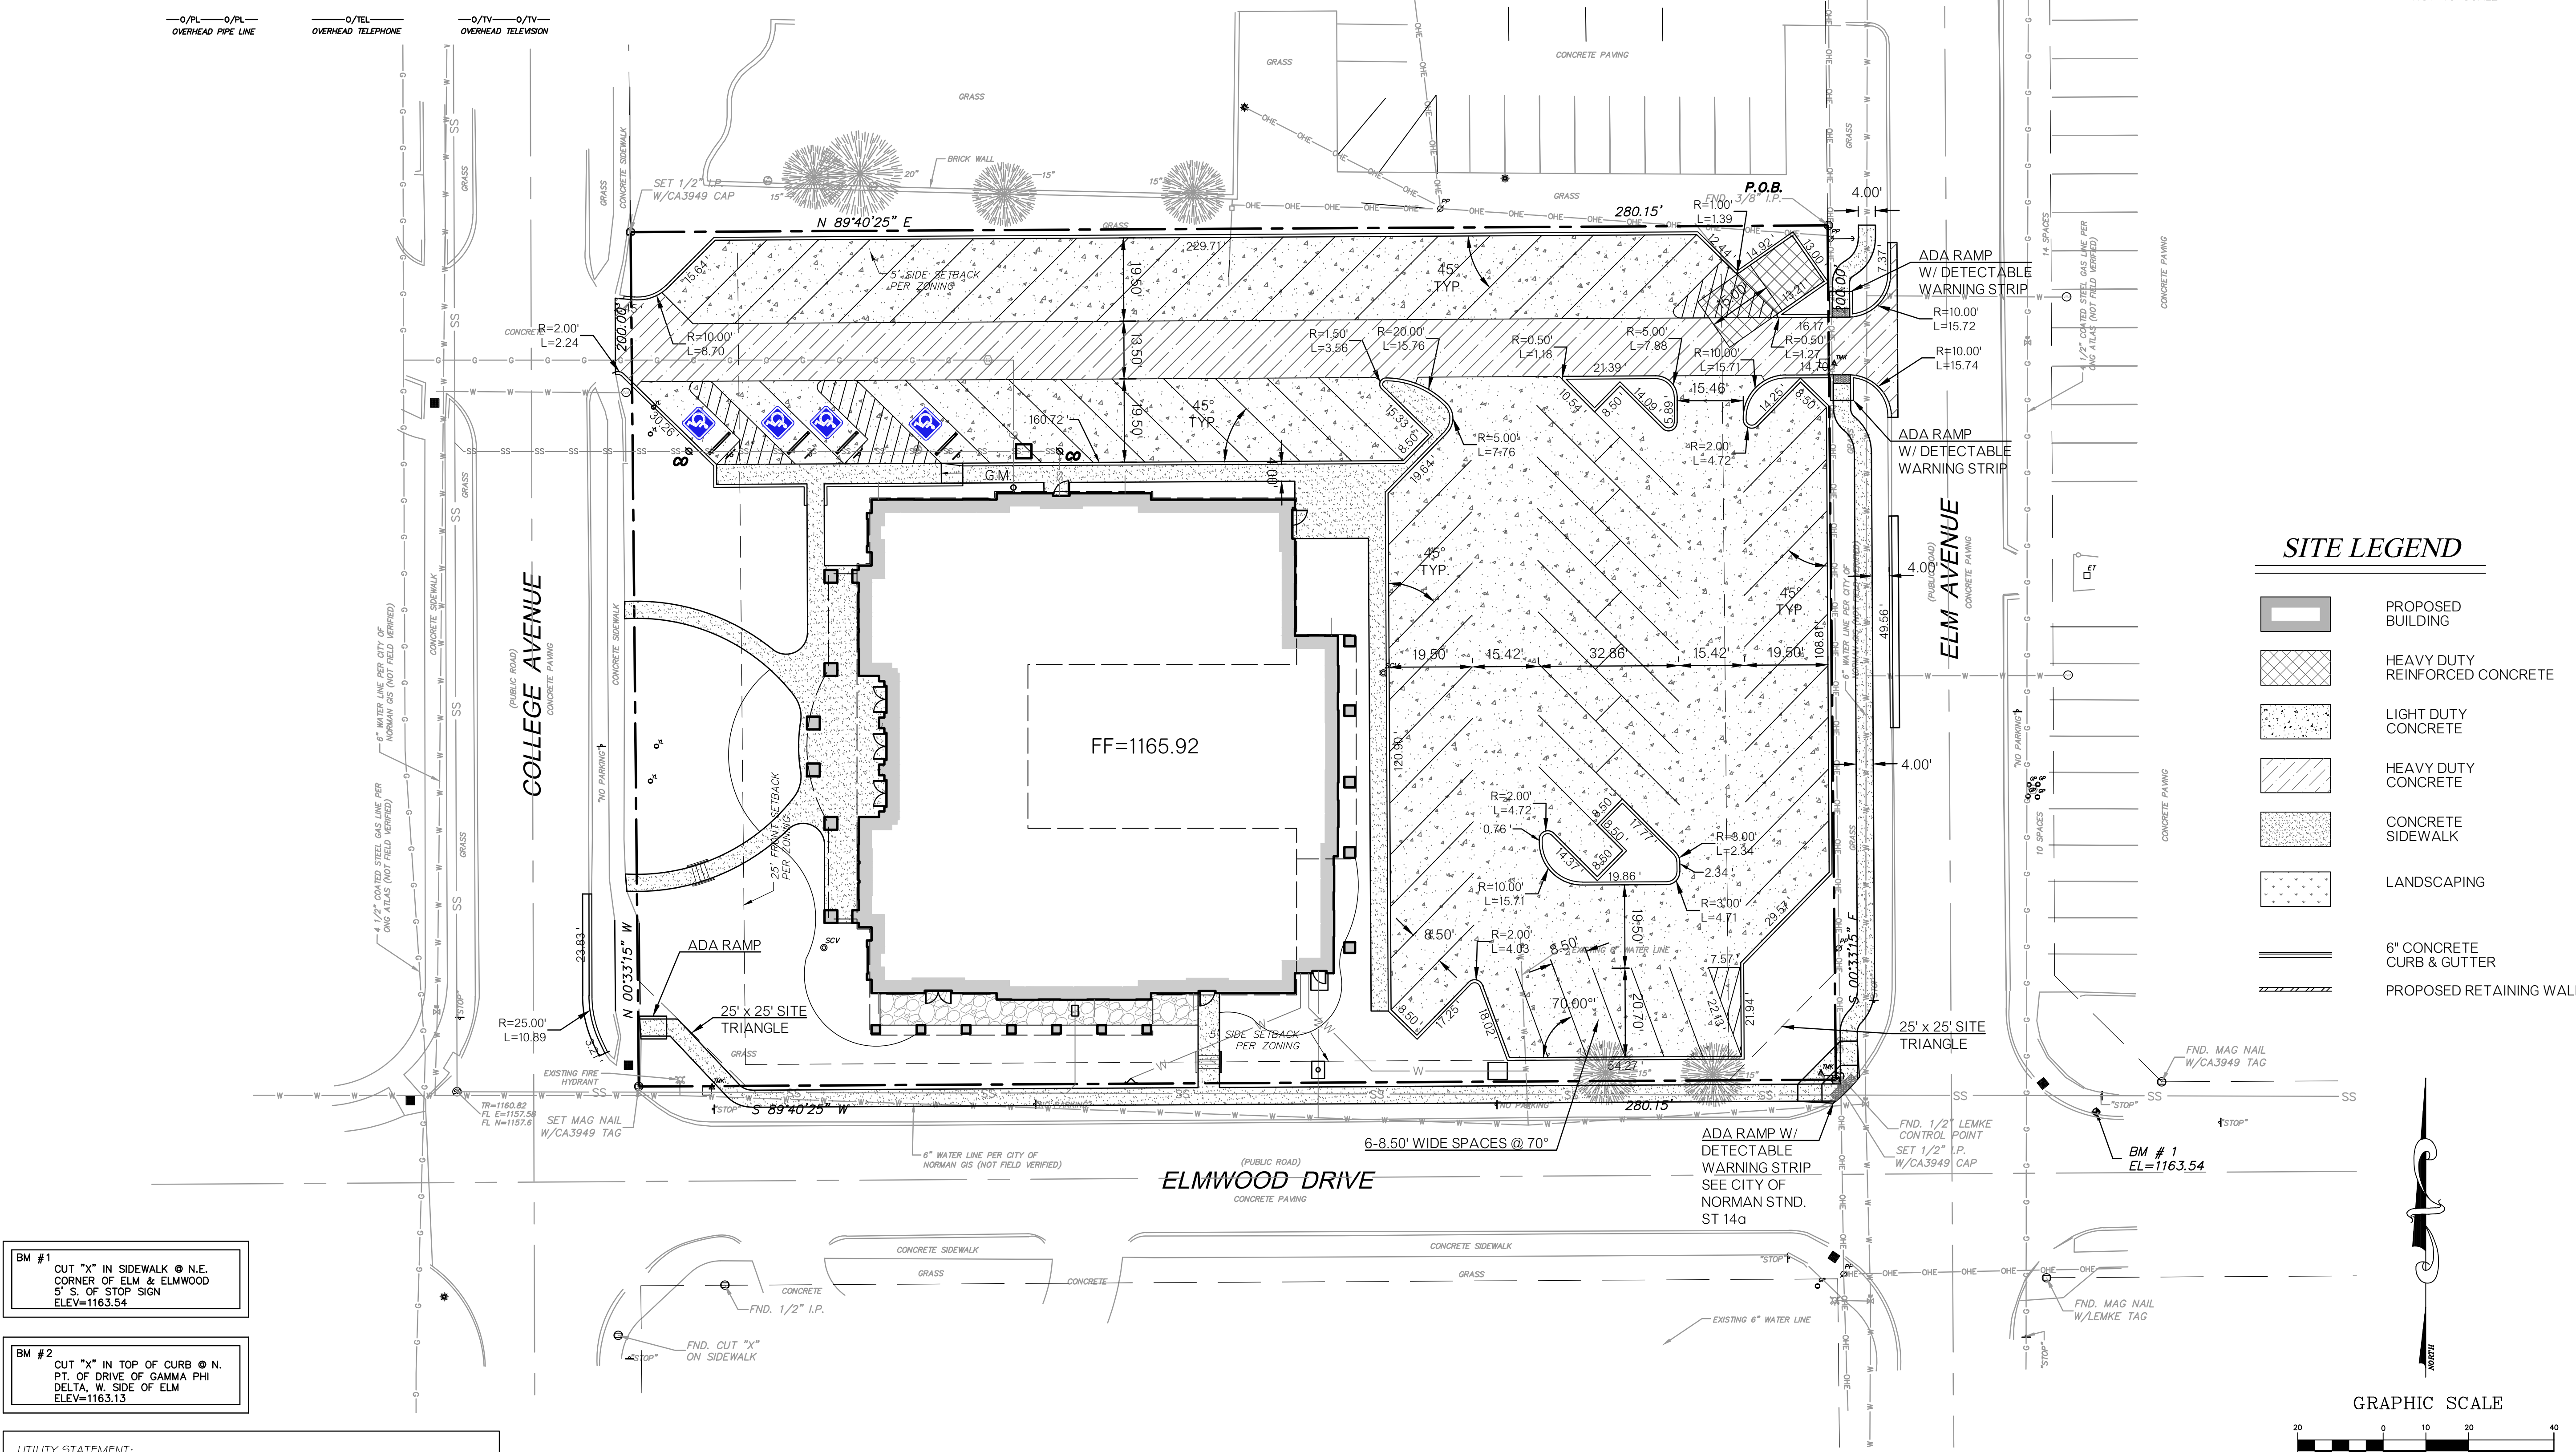

SITE LEGEND

CONSULTANT

REVISIONS

PRELIMINARY - NOT FOR CONSTRUCTION

A NEW HOUSE FOR

ALPHA CHI OMEGA PSI CHAPTER

11115 COLLEGE AVENUE, NORMAN, OK 73072

SITE PLAN

DATE: FEBRUARY 2020
JOB NO.: 2018137.00
SHEET NO.:

33.00

Z:\116258 Alpha Chi Omega Sorority at OUI\16258 PLAN wcc0086 2-01-21 02:45am

BM #1
CUT "X" IN SIDEWALK ☉ N.E.
CORNER OF ELM & ELMWOOD
5' S. OF STOP SIGN
ELEV=1163.54

BM #2
CUT "X" IN TOP OF CURB ☉ N.
PT. OF DRIVE OF GAMMA PHI
DELTA, W. SIDE OF ELM
ELEV=1163.13

UTILITY STATEMENT:

THE UNDERGROUND UTILITIES SHOWN HAVE BEEN LOCATED FROM FIELD SURVEY INFORMATION AND EXISTING DRAWINGS. THE SURVEYOR & ENGINEER MAKES NO GUARANTEE THAT THE UNDERGROUND UTILITIES SHOWN CORRESPOND TO ALL SUCH UTILITIES IN THE AREA. THE CONTRACTOR SHALL BE RESPONSIBLE FOR VERIFYING THE LOCATION OF ANY UTILITIES NOT SHOWN OR ABANDONED. THE SURVEYOR & ENGINEER FURTHER DOES NOT WARRANT THAT THE UNDERGROUND UTILITIES SHOWN ARE IN THE EXACT LOCATION INDICATED ALTHOUGH HE DOES CERTIFY THAT THEY ARE LOCATED AS ACCURATELY AS POSSIBLE FROM INFORMATION AVAILABLE. THE SURVEYOR & ENGINEER HAS NOT PHYSICALLY LOCATED THE UNDERGROUND UTILITIES. CONTRACTOR IS RESPONSIBLE IN VERIFYING LOCATION OF UTILITIES.

OKIE 811
Know what's below
Call before you dig.

NOTE: REFER TO SHEET C-5 SITE
UTILITY PLAN FOR UNDERGROUND
UTILITY INFORMATION



SMITH ROBERT
SRE
BALDI

ENGINEERING SURVEYING PLANNING

OKLAHOMA CITY
100 N.E. 5th Street
Oklahoma City,
Oklahoma 73104
T: 405.840.7094
F: 405.840.9116
www.srbok.com

NORMAN
2500 McGee Drive
Suite 100
Norman, OK 73071
T: 405.418.2288
F: 405.418.2289
srb@srbok.com